
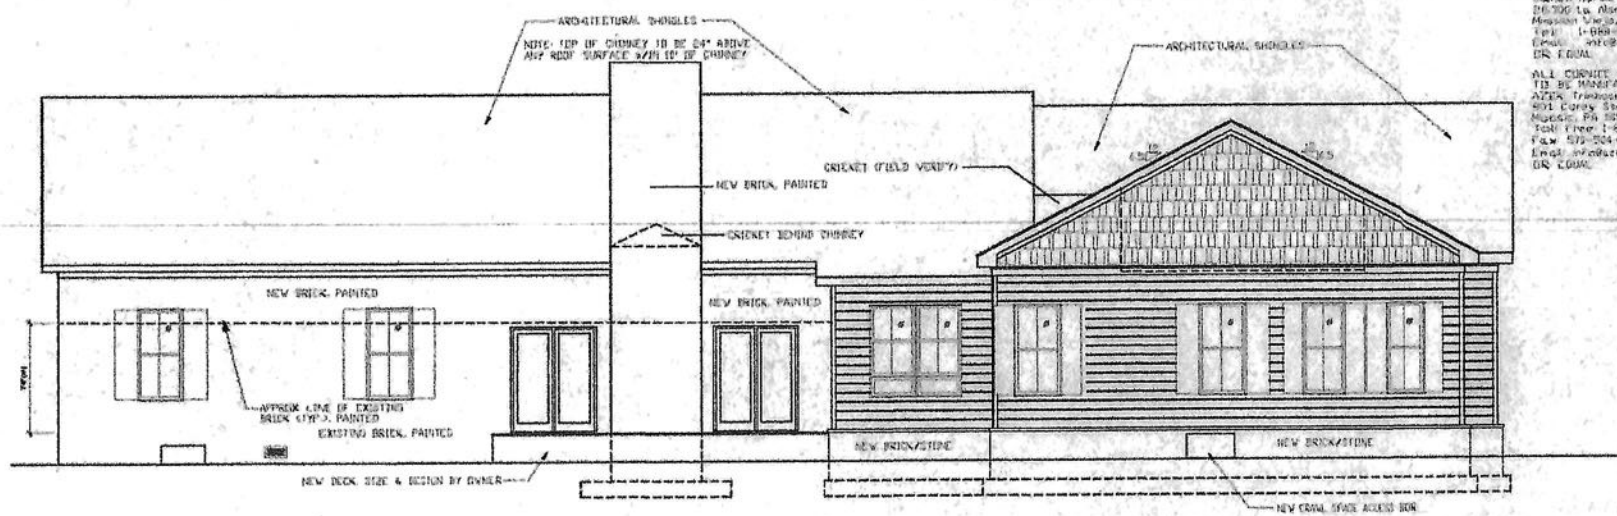


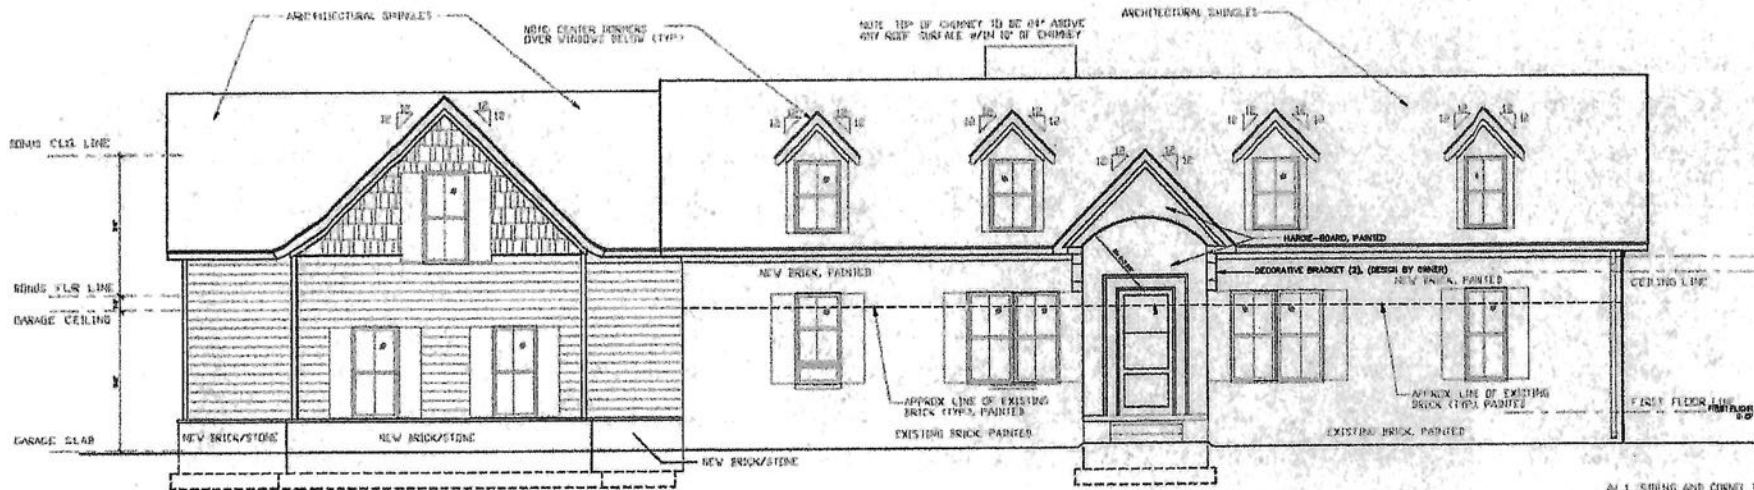

EXTERIOR ELEVATION NOTES

1. DETAIL OF ROOF FLASHING AT ALL INTERIORS IN EXTERIOR WALL, ALL WINDOWS, DOORS, GABLE ENDS, ETC. TO BE DONE BY ROOFER AND GUTTER WORK.
2. DETAIL OF ROOF FLASHING AT ALL INTERIORS IN EXTERIOR WALL, ALL WINDOWS, DOORS, GABLE ENDS, ETC. TO BE DONE BY ROOFER AND GUTTER WORK.
3. DETAIL OF ROOF FLASHING AT ALL INTERIORS IN EXTERIOR WALL, ALL WINDOWS, DOORS, GABLE ENDS, ETC. TO BE DONE BY ROOFER AND GUTTER WORK.


FRONT & REAR ELEVATIONS

SCALE = 1/4" = 1'-0"

ALL SIDING AND CORNER BRICKS
TO BE MANUFACTURED BY
JAMES HARDIE BUILDING PRODUCTS
26100 La Brea Ave., Suite 200
Van Nuys, California 91411
Tel: 1-800-552-7343
Email: info@jameshardie.com
OR, EQUAL

ALL CORNER AND TRIM BRICKS
TO BE MANUFACTURED BY
ALFA TRIMMERS
4011 Corby Street
Myrtle Beach, SC 29577
Tel: 1-877-679-0000
Fax: 843-204-1010
Email: info@alfatrim.com
OR, EQUAL

W. MICHAEL DAVIS, ARCHITECT RESIDENTIAL & COMMERCIAL ARCHITECTURE 106 PARK GLEN NASHVILLE, TN 37204 (615) 243-2061 (cell) wmdavis@comcast.net	
ANTHONY & KELLY HEATH 1613 HARPER-PEYTONSVILLE RD. THOMPSON STATION, TENNESSEE	
File: JMD Checked: JMD Project: E. HEATH Issue: 07/22/2013	07/22/2013
A-2.1	

 


REBUILDING ROOF FROM A STEEP PITCH CONSTRUCTION BY TAKING THROUGH ROOF AND FINISHING BY LOWER PITCH TO BE IN LINE WITH ADJACENT HOUSE

NEW BRICK

EXISTING BRICK

 SECTION : EXISTING RESIDENCE



ALL CORNICE AND TRIM SHOWN
TO BE MANUFACTURED BY:
ATEK Trimmings
930 Carey Street
Middletown, PA 17057
Toll free 1-877-270-0930
Fax: 717-664-1035
Email: info@atek.com
IN 1994

EXTERIOR ELEVATION NOTES:

- [illegible]


NEW LEFT & RIGHT SIDE ELEVATIONS

SCALE = 1/4" = 1'-0"

NOTED: This set of drawings for a nation designed home is the intellectual property of W. MICHAEL DAVIS, ARCHITECT. This drawing is loaned to you for your use only and is not to be reproduced, copied, or otherwise used in any way without the written consent of W. MICHAEL DAVIS, ARCHITECT. Any reproduction or use of this drawing without the written consent of W. MICHAEL DAVIS, ARCHITECT is strictly prohibited. This drawing is loaned to you for your use only and is not to be reproduced, copied, or otherwise used in any way without the written consent of W. MICHAEL DAVIS, ARCHITECT. Any reproduction or use of this drawing without the written consent of W. MICHAEL DAVIS, ARCHITECT is strictly prohibited.

These drawings are not to be reproduced by anyone in any manner including photocopying, scanning, photographing, drawing, or otherwise. They may not be used by anyone for reproduction, sale, or otherwise without the written consent of W. MICHAEL DAVIS, ARCHITECT. Any reproduction or use of these drawings without the written consent of W. MICHAEL DAVIS, ARCHITECT is strictly prohibited. This drawing is loaned to you for your use only and is not to be reproduced, copied, or otherwise used in any way without the written consent of W. MICHAEL DAVIS, ARCHITECT. Any reproduction or use of this drawing without the written consent of W. MICHAEL DAVIS, ARCHITECT is strictly prohibited.

W. MICHAEL DAVIS, ARCHITECT © 2009

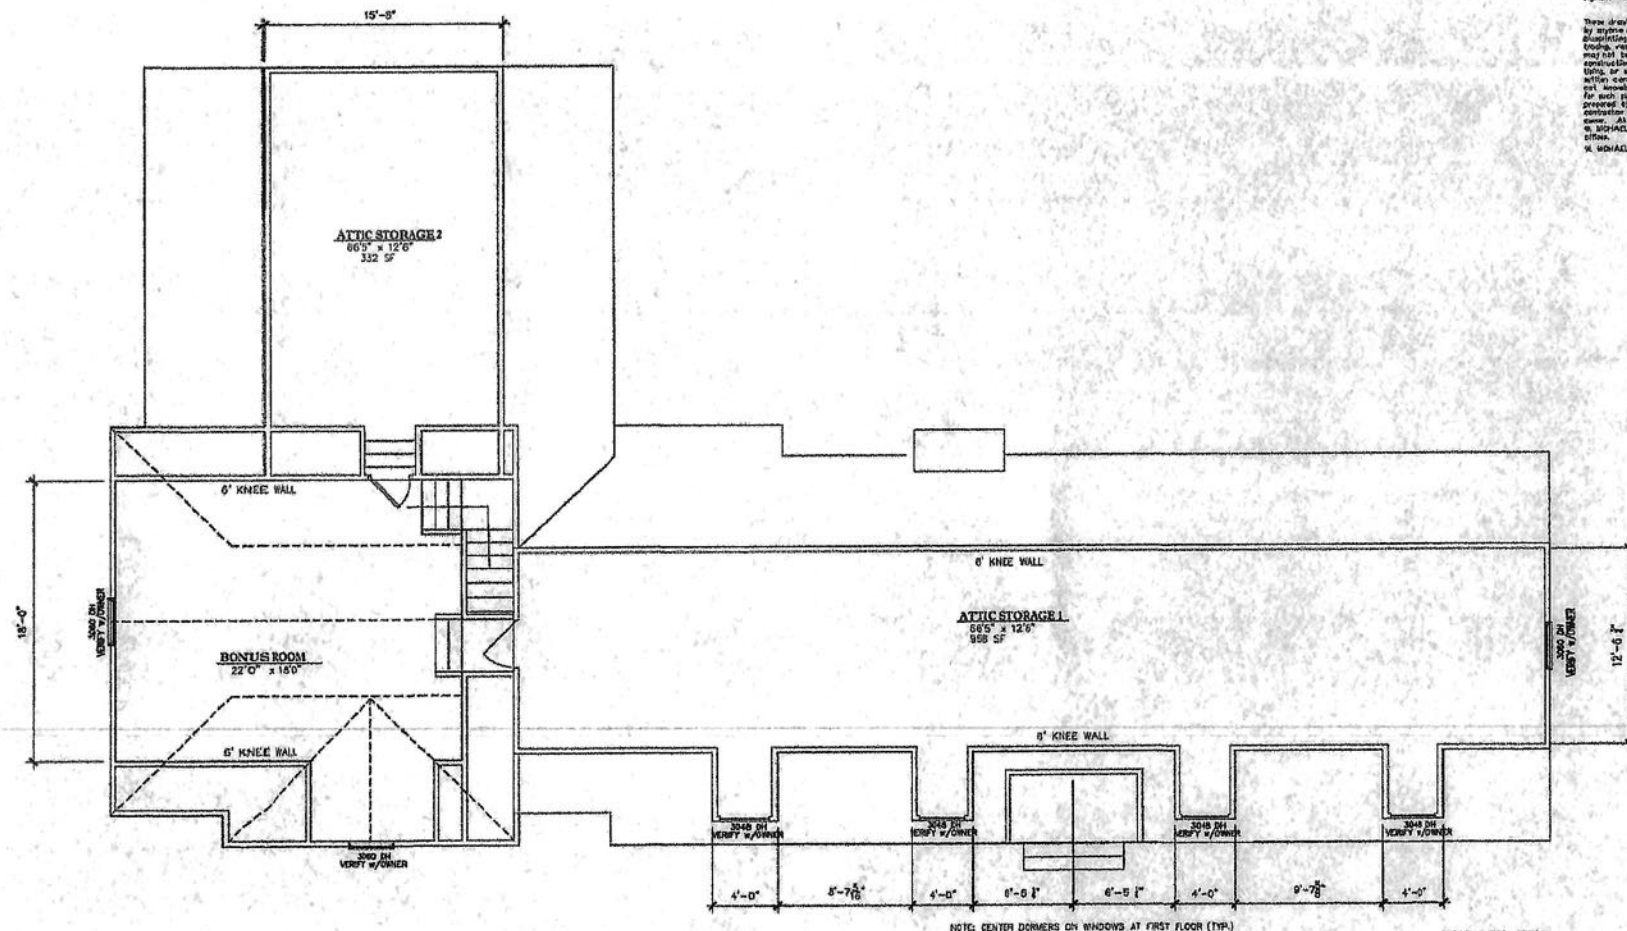

NOTE: CENTER DOWNERS ON WINDOWS AT FIRST FLOOR (TYP.)

EXISTING RESIDENCE	1513 SF
FIRST FLOOR ADDITION LIVING AREA	338 SF
TOTAL FIRST FLOOR LIVING AREA	2451 SF
BONUS ROOM OVER NEW GARAGE	446 SF
TOTAL LIVING AREA EXISTING & NEW	2897 SF
AREAS NOT HEATED OR COOLED	
2 CAR GARAGE	814 SF
FRONT PORCH	195 SF
ATTIC AREA 1	658 SF
ATTIC AREA 2	332 SF
UNHEATED FLOOR AREA	2060 SF
TOTAL GROSS AREA	4958 SF

NOTE: TO CONSTRUCTION OWNER: THIS SET OF DRAWINGS IS FOR INFORMATION ONLY. IT IS NOT TO BE USED FOR CONSTRUCTION. THE CONSTRUCTION OF THIS PROJECT IS THE RESPONSIBILITY OF THE CONSTRUCTION OWNER. THE ARCHITECT IS NOT RESPONSIBLE FOR THE CONSTRUCTION OF THIS PROJECT.

FIRST FLOOR NOTES

1. SEE FIRST FLOOR DRAWINGS FOR ALL STRUCTURAL, MECHANICAL, ELECTRICAL, AND PLUMBING DETAILS. SEE ALSO FIRST FLOOR DRAWINGS FOR ALL STRUCTURAL, MECHANICAL, ELECTRICAL, AND PLUMBING DETAILS.
2. SEE FIRST FLOOR DRAWINGS FOR ALL STRUCTURAL, MECHANICAL, ELECTRICAL, AND PLUMBING DETAILS. SEE ALSO FIRST FLOOR DRAWINGS FOR ALL STRUCTURAL, MECHANICAL, ELECTRICAL, AND PLUMBING DETAILS.
3. SEE FIRST FLOOR DRAWINGS FOR ALL STRUCTURAL, MECHANICAL, ELECTRICAL, AND PLUMBING DETAILS. SEE ALSO FIRST FLOOR DRAWINGS FOR ALL STRUCTURAL, MECHANICAL, ELECTRICAL, AND PLUMBING DETAILS.
4. SEE FIRST FLOOR DRAWINGS FOR ALL STRUCTURAL, MECHANICAL, ELECTRICAL, AND PLUMBING DETAILS. SEE ALSO FIRST FLOOR DRAWINGS FOR ALL STRUCTURAL, MECHANICAL, ELECTRICAL, AND PLUMBING DETAILS.
5. SEE FIRST FLOOR DRAWINGS FOR ALL STRUCTURAL, MECHANICAL, ELECTRICAL, AND PLUMBING DETAILS. SEE ALSO FIRST FLOOR DRAWINGS FOR ALL STRUCTURAL, MECHANICAL, ELECTRICAL, AND PLUMBING DETAILS.
6. SEE FIRST FLOOR DRAWINGS FOR ALL STRUCTURAL, MECHANICAL, ELECTRICAL, AND PLUMBING DETAILS. SEE ALSO FIRST FLOOR DRAWINGS FOR ALL STRUCTURAL, MECHANICAL, ELECTRICAL, AND PLUMBING DETAILS.

BONUS RM & ATTIC FLOOR PLAN

SCALE: 1/4" = 1'-0"

W. MICHAEL DAVIS, ARCHITECT

RESIDENTIAL & COMMERCIAL ARCHITECTURE

106 PARK GLEN NASHVILLE, TN 37204

(615) 243-2081 (cell) wmdavis8@comcast.net

ANTHONY & KELLY HEATH

4613 HARPEETH-PEYTONSVILLE RD.

THOMPSON STATION, TENNESSEE

RENOVATIONS & ADDITIONS TO THE RESIDENCE OF:

ANTHONY & KELLY HEATH

4613 HARPEETH-PEYTONSVILLE RD.

THOMPSON STATION, TENNESSEE

DATE: 02/22/2009

PROJECT: C-HEATH

DATE: 02/18/2009

A-1.4

XX

